

ATTACHMENT 1

DENVER WATER DENVER, COLORADO

GROSS RESERVOIR
HYDROELECTRIC PROJECT
FERC NO 2035


GENERAL DESIGN DRAWINGS & PROJECT BOUNDARY MAP

BOARD OF WATER COMMISSIONERS
DENVER, COLORADO


Denise S. Maes - President
H. J. Barry - Manager

Jon L. Diebel - Director of Engineering

PROJECT
LOCATION

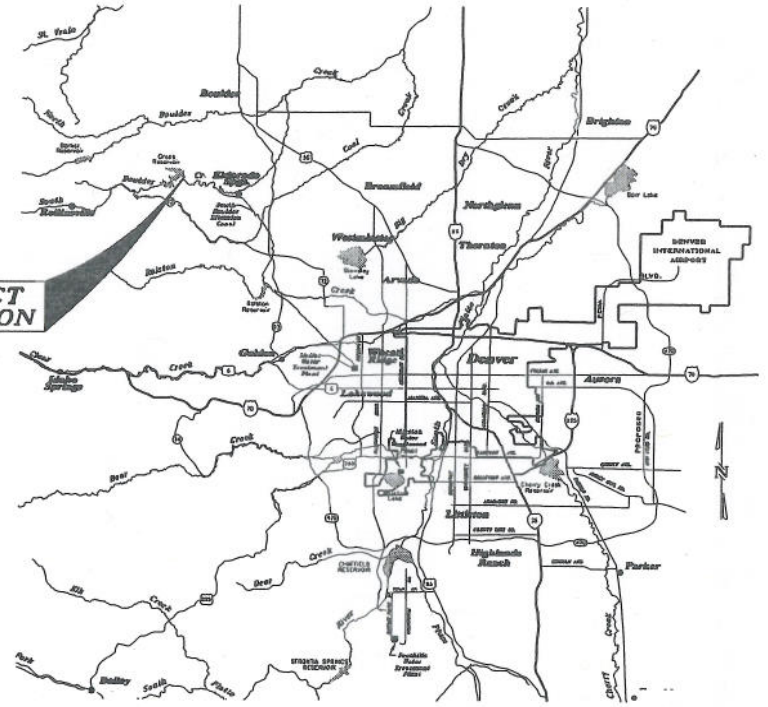

LOCATION MAP
6 MILES (APPROX)
0 2 4 6

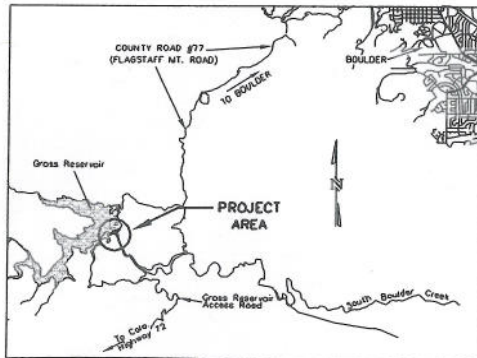

VICINITY MAP

2000 0 2000 4000
SCALE IN FEET

SHEET INDEX:

- SHEET 1 - LOCATION MAPS AND SHEET INDEX
- SHEET 2 - MECHANICAL SITE PLAN & PERFORMANCE ENVELOPE
- SHEET 3 - HYDRAULIC PIPING PLAN AND PROFILE
- SHEET 4 - HYDRAULIC PIPING PLAN AND PROFILE
- SHEET 5 - MECHANICAL EQUIPMENT PLAN
- SHEET 6 - MECHANICAL EQUIPMENT SECTION
- SHEET 7 - TRANSMISSION LINE DETAILS
- SHEET 8 - PROJECT BOUNDARY MAP

VICINITY MAP
BAR IS ONE INCH ON ORIGINAL DRAWING
OR DIMENSIONS IN FEET
IF NOT ONE INCH ON THIS SHEET, ADJUST SCALES ACCORDINGLY




No.	Description	Date	By
REVISIONS			
Spec. _____		Field Book No. _____	
AS CONSTRUCTED		Date: _____	By: _____

DENVER WATER	
1500 West 12th Avenue - Denver, Colorado 80202 Phone (303) 733-8000 - Telefax: (303) 733-8851	
GROSS RESERVOIR	
HYDROELECTRIC PROJECT	
FERC NO 2035	
GENERAL DRAWINGS & PROJECT BOUNDARY MAP	
LOCATION MAP AND SHEET INDEX	
Scale: <u>AS SHOWN</u>	Date: <u>SEPT 2003</u>
Drawn: <u>D. ROMERO</u>	Checked: <u>GH/SR/LA/MK</u>
Approved: _____	Dr. _____ No. _____

6th PRINCIPAL MERIDIAN, COLORADO

LEGEND

 - PROJECT BOUNDARY
- DENVER WATER PROPERTY BOUNDARY
- DENVER WATER PROPERTY
- DENVER WATER RIGHT OF WAY
- U.S. FOREST SERVICE BOUNDARY
- BUREAU OF LAND MANAGEMENT
- DENVER WATER PROPERTY
- U.S. FOREST SERVICE LAND
- PRIVATE

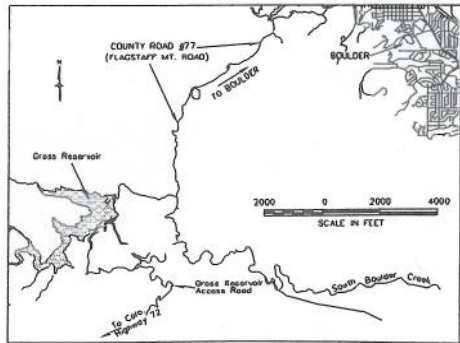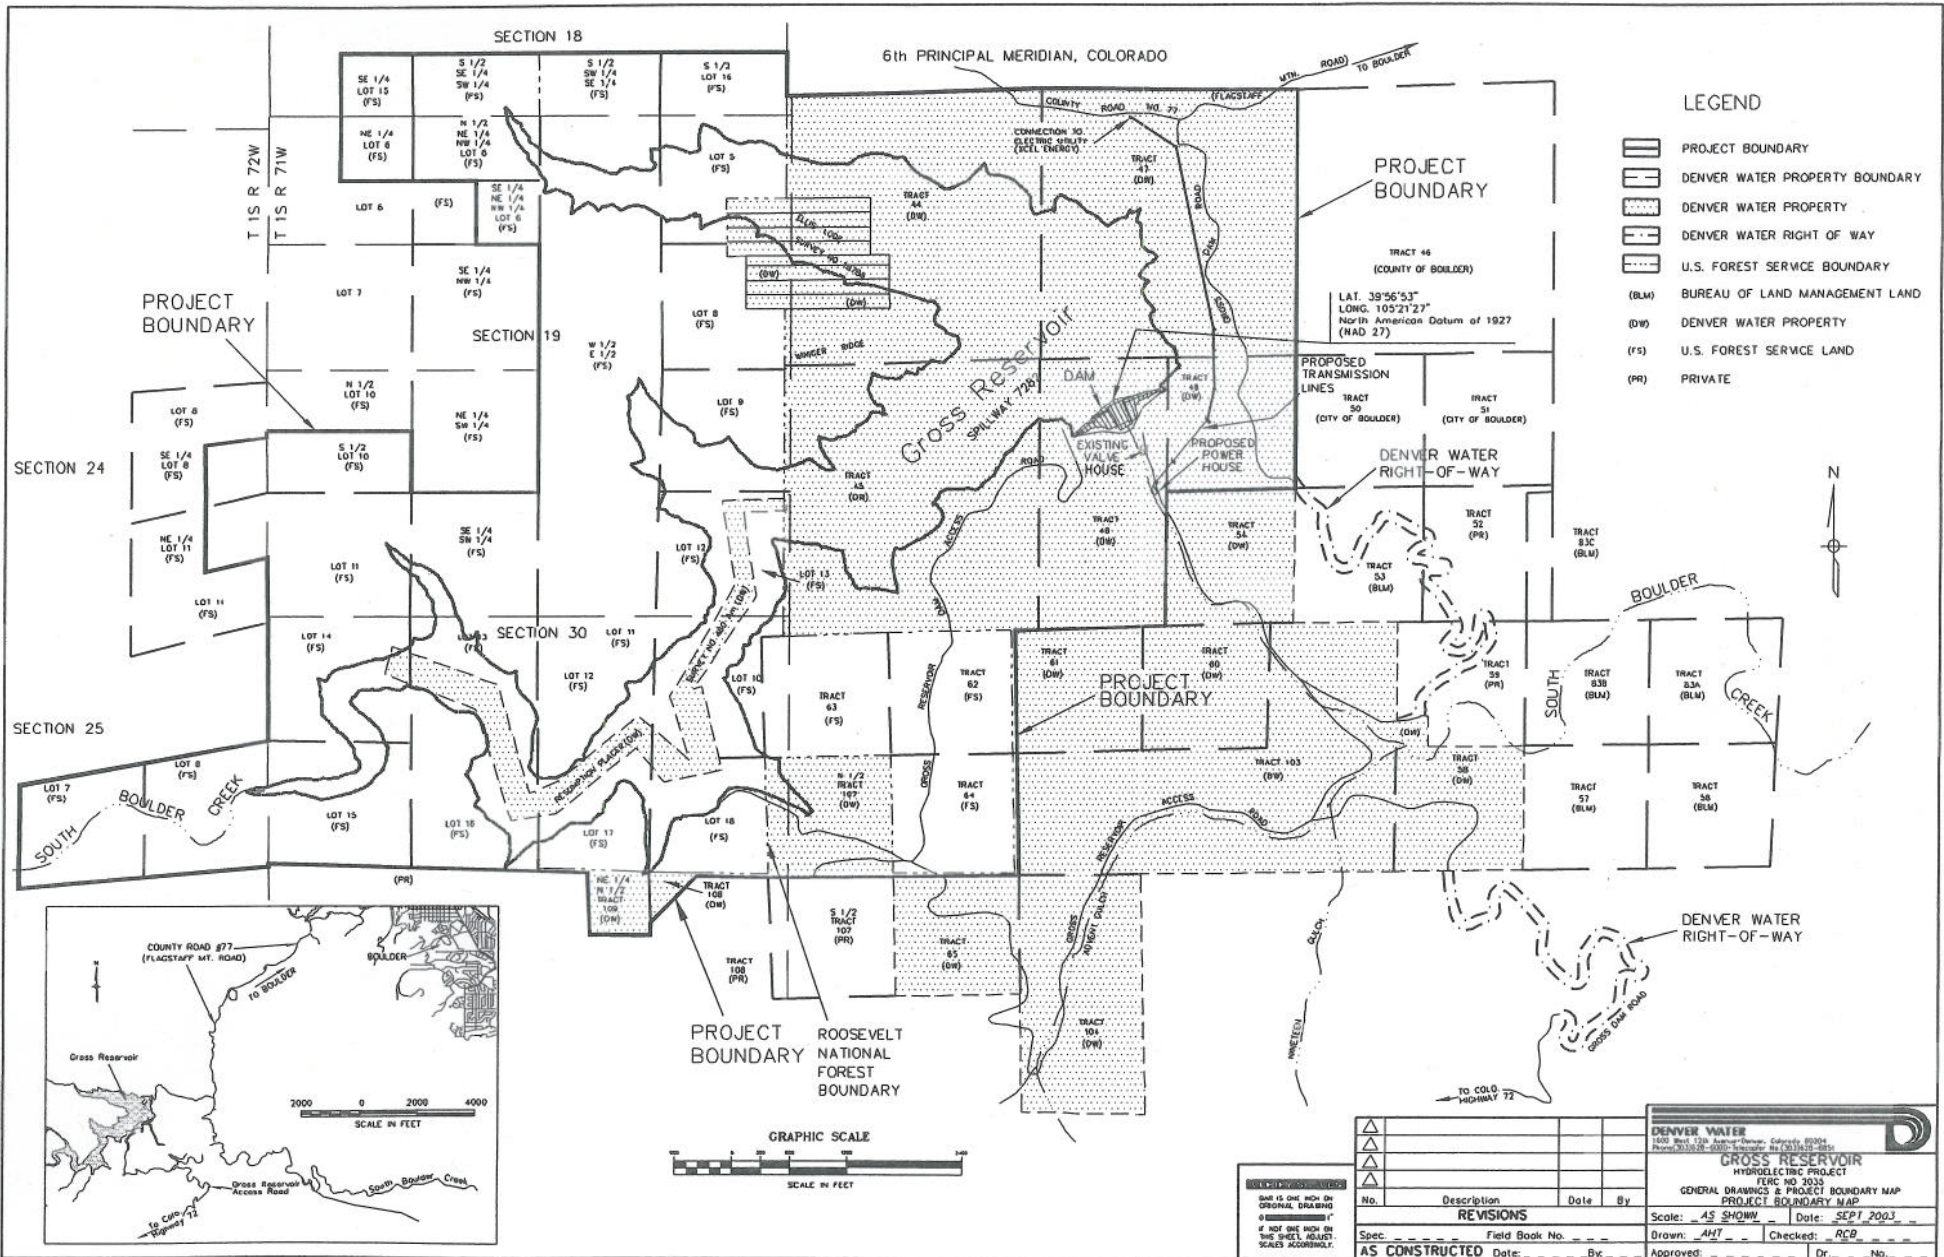

REVISIONS			
No.	Description	Date	By

Spec	Field Book No.	Brown	AHT	Checked	RCB
AS CONSTRUCTED	Date	By	Approved	Dr	No.

DENVER WATER
 1600 West 12th Avenue, Denver, Colorado 80202
 Phone: 303.733.6000 - Fax: 303.733.6001

GROSS RESERVOIR
 HYDROELECTRIC PROJECT
 FERC NO 2035
 GENERAL DRAWINGS & PROJECT BOUNDARY MAP
 PROJECT BOUNDARY MAP

Scale: AS SHOWN Date: SEPT 2003
 Approved: AHT Checked: RCB
 SHEET 08 OF 08 SHEETS